


US EPA ARCHIVE DOCUMENT

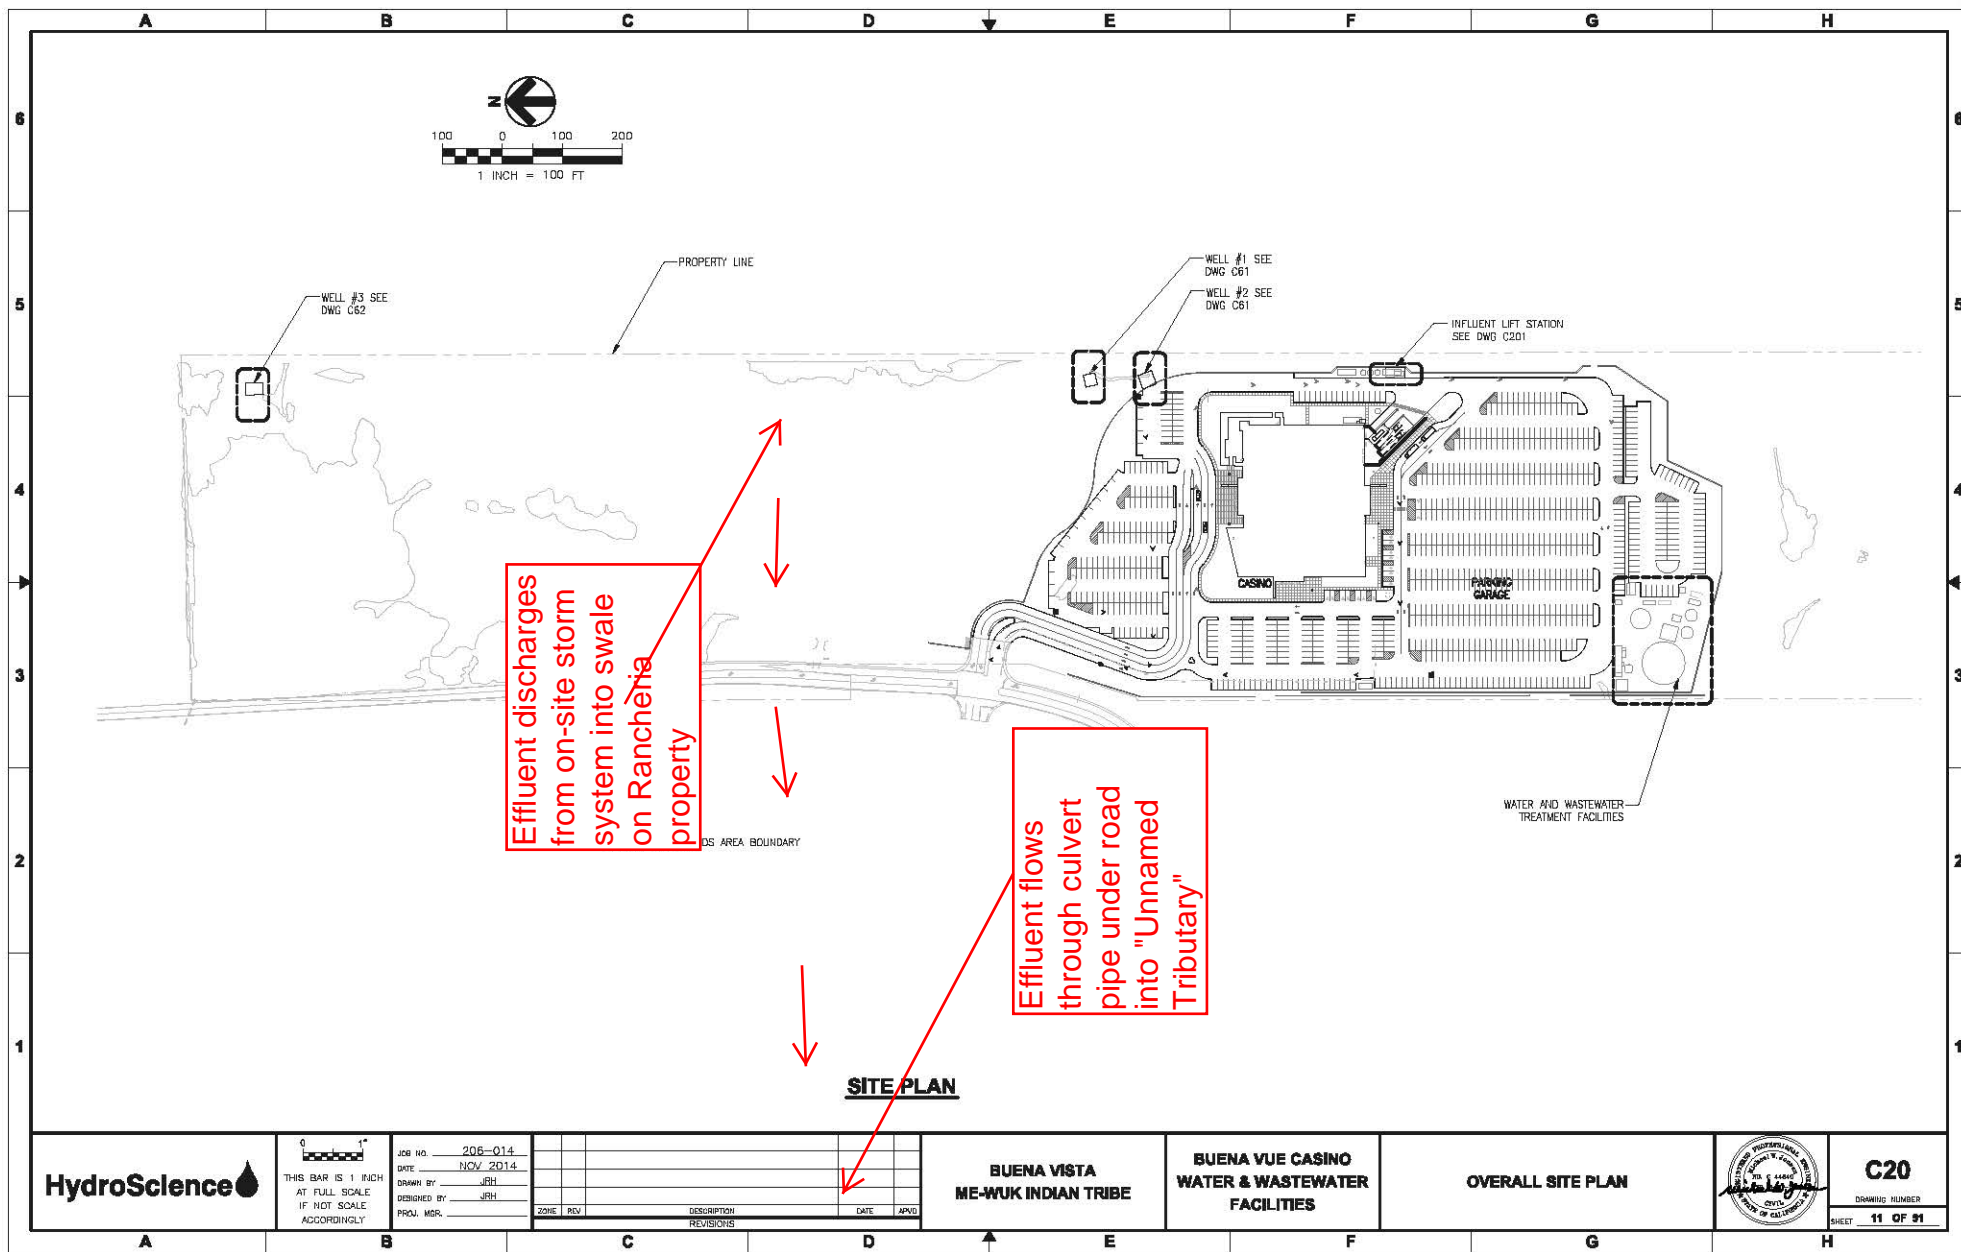

HydroScience

0 1"
 THIS BAR IS 1 INCH
 AT FULL SCALE.
 IF NOT SCALE
 ACCORDINGLY

JOB NO. 206-Q14
 DATE NOV 2014
 DRAWN BY JRH
 DESIGNED BY JRH
 PROJ. MGR.

ZONE	REV	DESCRIPTION	DATE	APVD
		REVISIONS		


BUENA VISTA
 ME-WUK INDIAN TRIBE

BUENA VUE CASINO
 WATER & WASTEWATER
 FACILITIES

OVERALL SITE PLAN



C20
 DRAWING NUMBER
 SHEET 11 OF 31

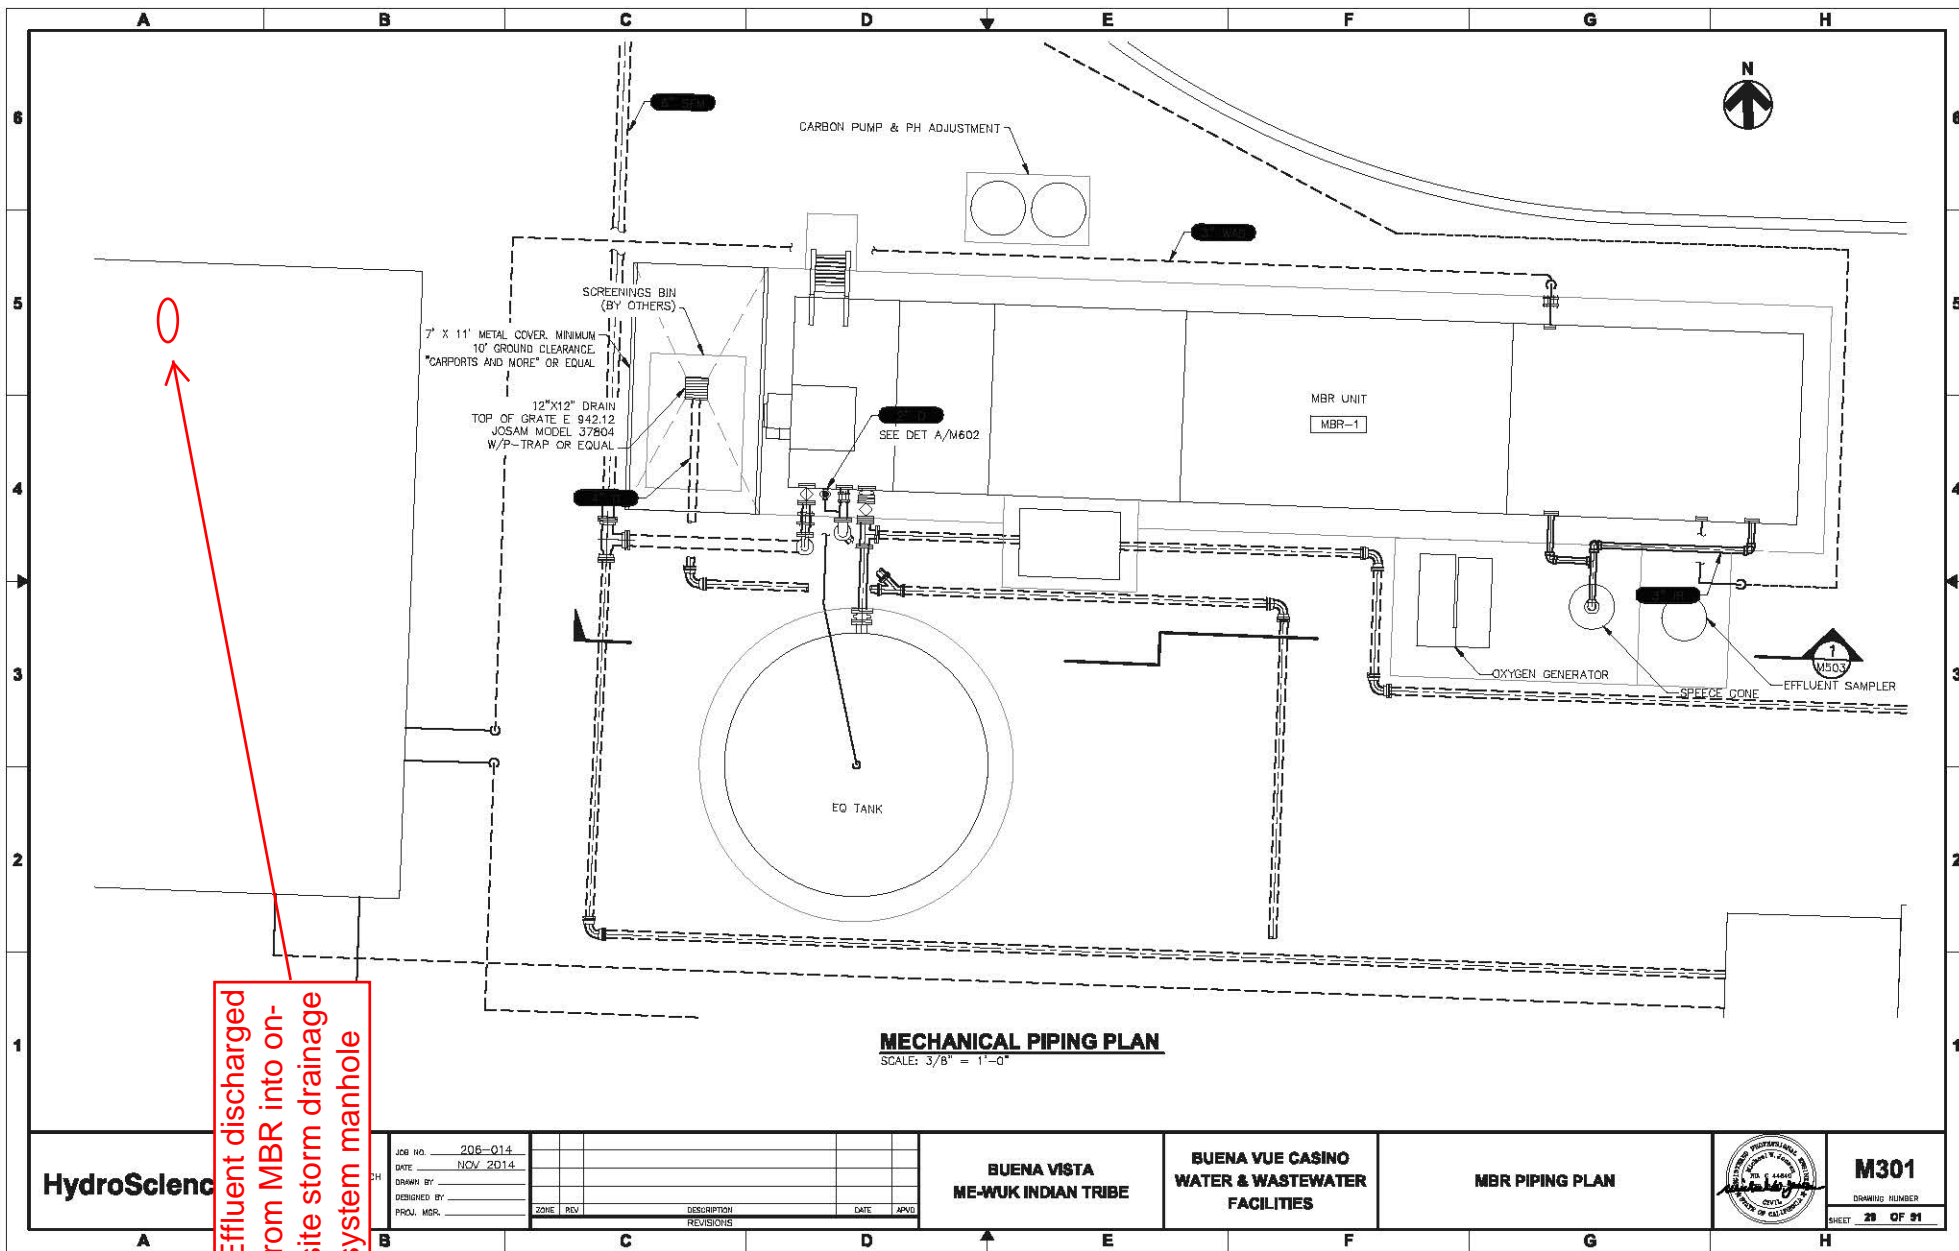

Effluent discharged from MBR into on-site storm drainage system manhole

HydroScience

JOB NO.	206-Q14				
DATE	NOV 2014				
DRAWN BY					
DESIGNED BY					
PROJ. MGR.					
	ZONE	REV	DESCRIPTION	DATE	APPROV
			REVISIONS		

BUENA VISTA
ME-WUK INDIAN TRIBE

BUENA VUE CASINO
WATER & WASTEWATER
FACILITIES

MBR PIPING PLAN



M301

DRAWING NUMBER

SHEET 28 OF 31